


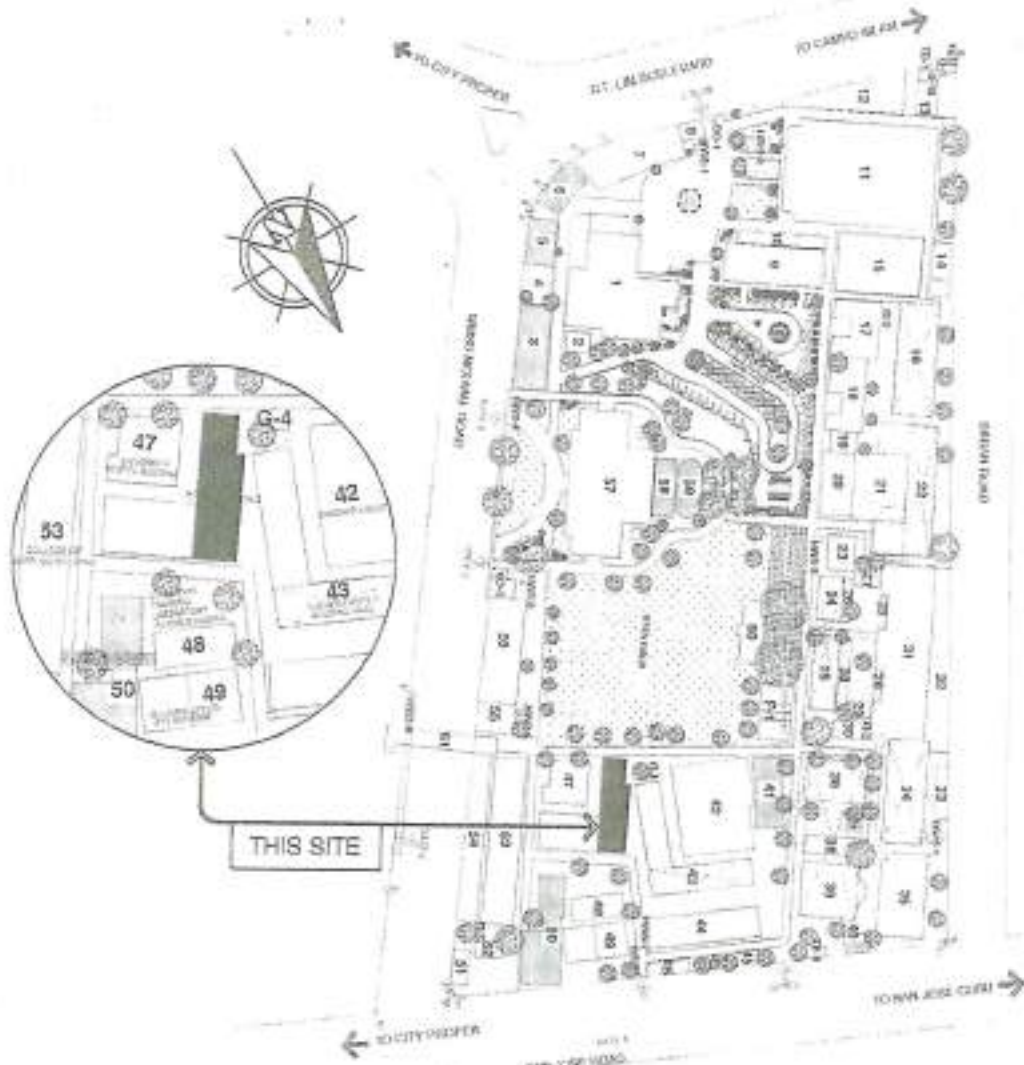

LOCATION PLAN
WESTERN MINDANAO STATE UNIVERSITY
CAMPUS A LOT-1
NOT TO SCALE



LOBBY PERSPECTIVE



FUNCTION ROOM PERSPECTIVE



KITCHEN PERSPECTIVE

TABLE OF CONTENTS

ARCHITECTURAL	A01 - SHEET - 1 LOCATION PLAN STORY RESPONSIVE FUNCTION ROOM PERSPECTIVE LOBBY PERSPECTIVE	A12 - SHEET - 12 TOILET PLAN STORY RESPONSIVE A, B, C AND D FLOOR LAYOUT
	A02 - SHEET - 2 ELECTRIC PLAN	A13 - SHEET - 13 TOILET PLAN STORY RESPONSIVE A, B, C AND D FLOOR LAYOUT
	A03 - SHEET - 3 MECHANICAL PLAN	A14 - SHEET - 14 TOILET PLAN STORY RESPONSIVE A, B, C AND D FLOOR LAYOUT
	A04 - SHEET - 4 STORY RESPONSIVE SECTIONS	A15 - SHEET - 15 STORY RESPONSIVE SECTIONS STORY RESPONSIVE SECTION DETAILS
	A05 - SHEET - 5 CEILING	A16 - SHEET - 16 STORY RESPONSIVE SECTION DETAILS
	A06 - SHEET - 6 DOORS AND WINDOWS	A17 - SHEET - 17 STORY RESPONSIVE SECTION DETAILS
	A07 - SHEET - 7 BUILT UP STAIRS BUILT UP STAIRS	A18 - SHEET - 18 STORY RESPONSIVE SECTION DETAILS
	A08 - SHEET - 8 REFLECTED CEILING PLAN REFLECTED CEILING PLAN	A19 - SHEET - 19 STORY RESPONSIVE SECTION DETAILS
	A09 - SHEET - 9 REFLECTED CEILING PLAN REFLECTED CEILING PLAN	A20 - SHEET - 20 STORY RESPONSIVE SECTION DETAILS
	A10 - SHEET - 10 STORY RESPONSIVE SECTION DETAILS	
	A11 - SHEET - 11 STORY RESPONSIVE SECTION DETAILS	
STRUCTURAL	S01 - SHEET - 21 STORY RESPONSIVE SECTION DETAILS	
	S02 - SHEET - 22 STORY RESPONSIVE SECTION DETAILS	
	S03 - SHEET - 23 STORY RESPONSIVE SECTION DETAILS	
	S04 - SHEET - 24 STORY RESPONSIVE SECTION DETAILS	
	S05 - SHEET - 25 STORY RESPONSIVE SECTION DETAILS	
	S06 - SHEET - 26 STORY RESPONSIVE SECTION DETAILS	
	S07 - SHEET - 27 STORY RESPONSIVE SECTION DETAILS	
	S08 - SHEET - 28 STORY RESPONSIVE SECTION DETAILS	
ELECTRICAL	E01 - SHEET - 29 STORY RESPONSIVE SECTION DETAILS	
	E02 - SHEET - 30 STORY RESPONSIVE SECTION DETAILS	
	E03 - SHEET - 31 STORY RESPONSIVE SECTION DETAILS	
	E04 - SHEET - 32 STORY RESPONSIVE SECTION DETAILS	
AUXILIARY	AUX01 - SHEET - 33 STORY RESPONSIVE SECTION DETAILS	
	AUX02 - SHEET - 34 STORY RESPONSIVE SECTION DETAILS	
	AUX03 - SHEET - 35 STORY RESPONSIVE SECTION DETAILS	
	AUX04 - SHEET - 36 STORY RESPONSIVE SECTION DETAILS	

LAND USE AND ZONING

LINE AND GRADE

ARCHITECTURAL

STRUCTURAL


SANITARY

ELECTRICAL

MECHANICAL




DESIGNED BY ARCH. JOSEPH ANDREW L. SANIAL, UAP UNIVERSITY ARCHITECT	PROJECT TITLE RENOVATION OF COLLEGE OF HOME ECONOMICS LABORATORY, FUNCTION ROOM WITH PROVISION FOR FURNITURES AND FIXTURES	REQUESTER DR. LUCIA M. SANTOS, RND DEAN, COLLEGE OF HOME ECONOMICS	RECOMMENDING APPROVAL ARCH. JOSEPH ANDREW L. SANIAL, UAP DIRECTOR OF PHYSICAL PLANT AND ENGINEERING SERVICES	RECOMMENDING APPROVAL DR. JOSELITO D. MADRONAL VICE PRESIDENT FOR ADMIN AND FINANCE	APPROVED BY DR. MA. CAMILA A. OCHOTORENA SCHOOL DEPUTY	SHEET CONTENTS LOCATION PLAN STORY RESPONSIVE FUNCTION ROOM PERSPECTIVE LOBBY PERSPECTIVE DRAFTED BY AR. JESUS AR. SHERWIN	SHEET NO. A01 01/36	STARS WURJ
PRD: 0010677 PTR: 0000001 TNC: 415-013-005	LOCATION: TOWN LOT 1, DALAMAN, ZAMBOANGA CITY							

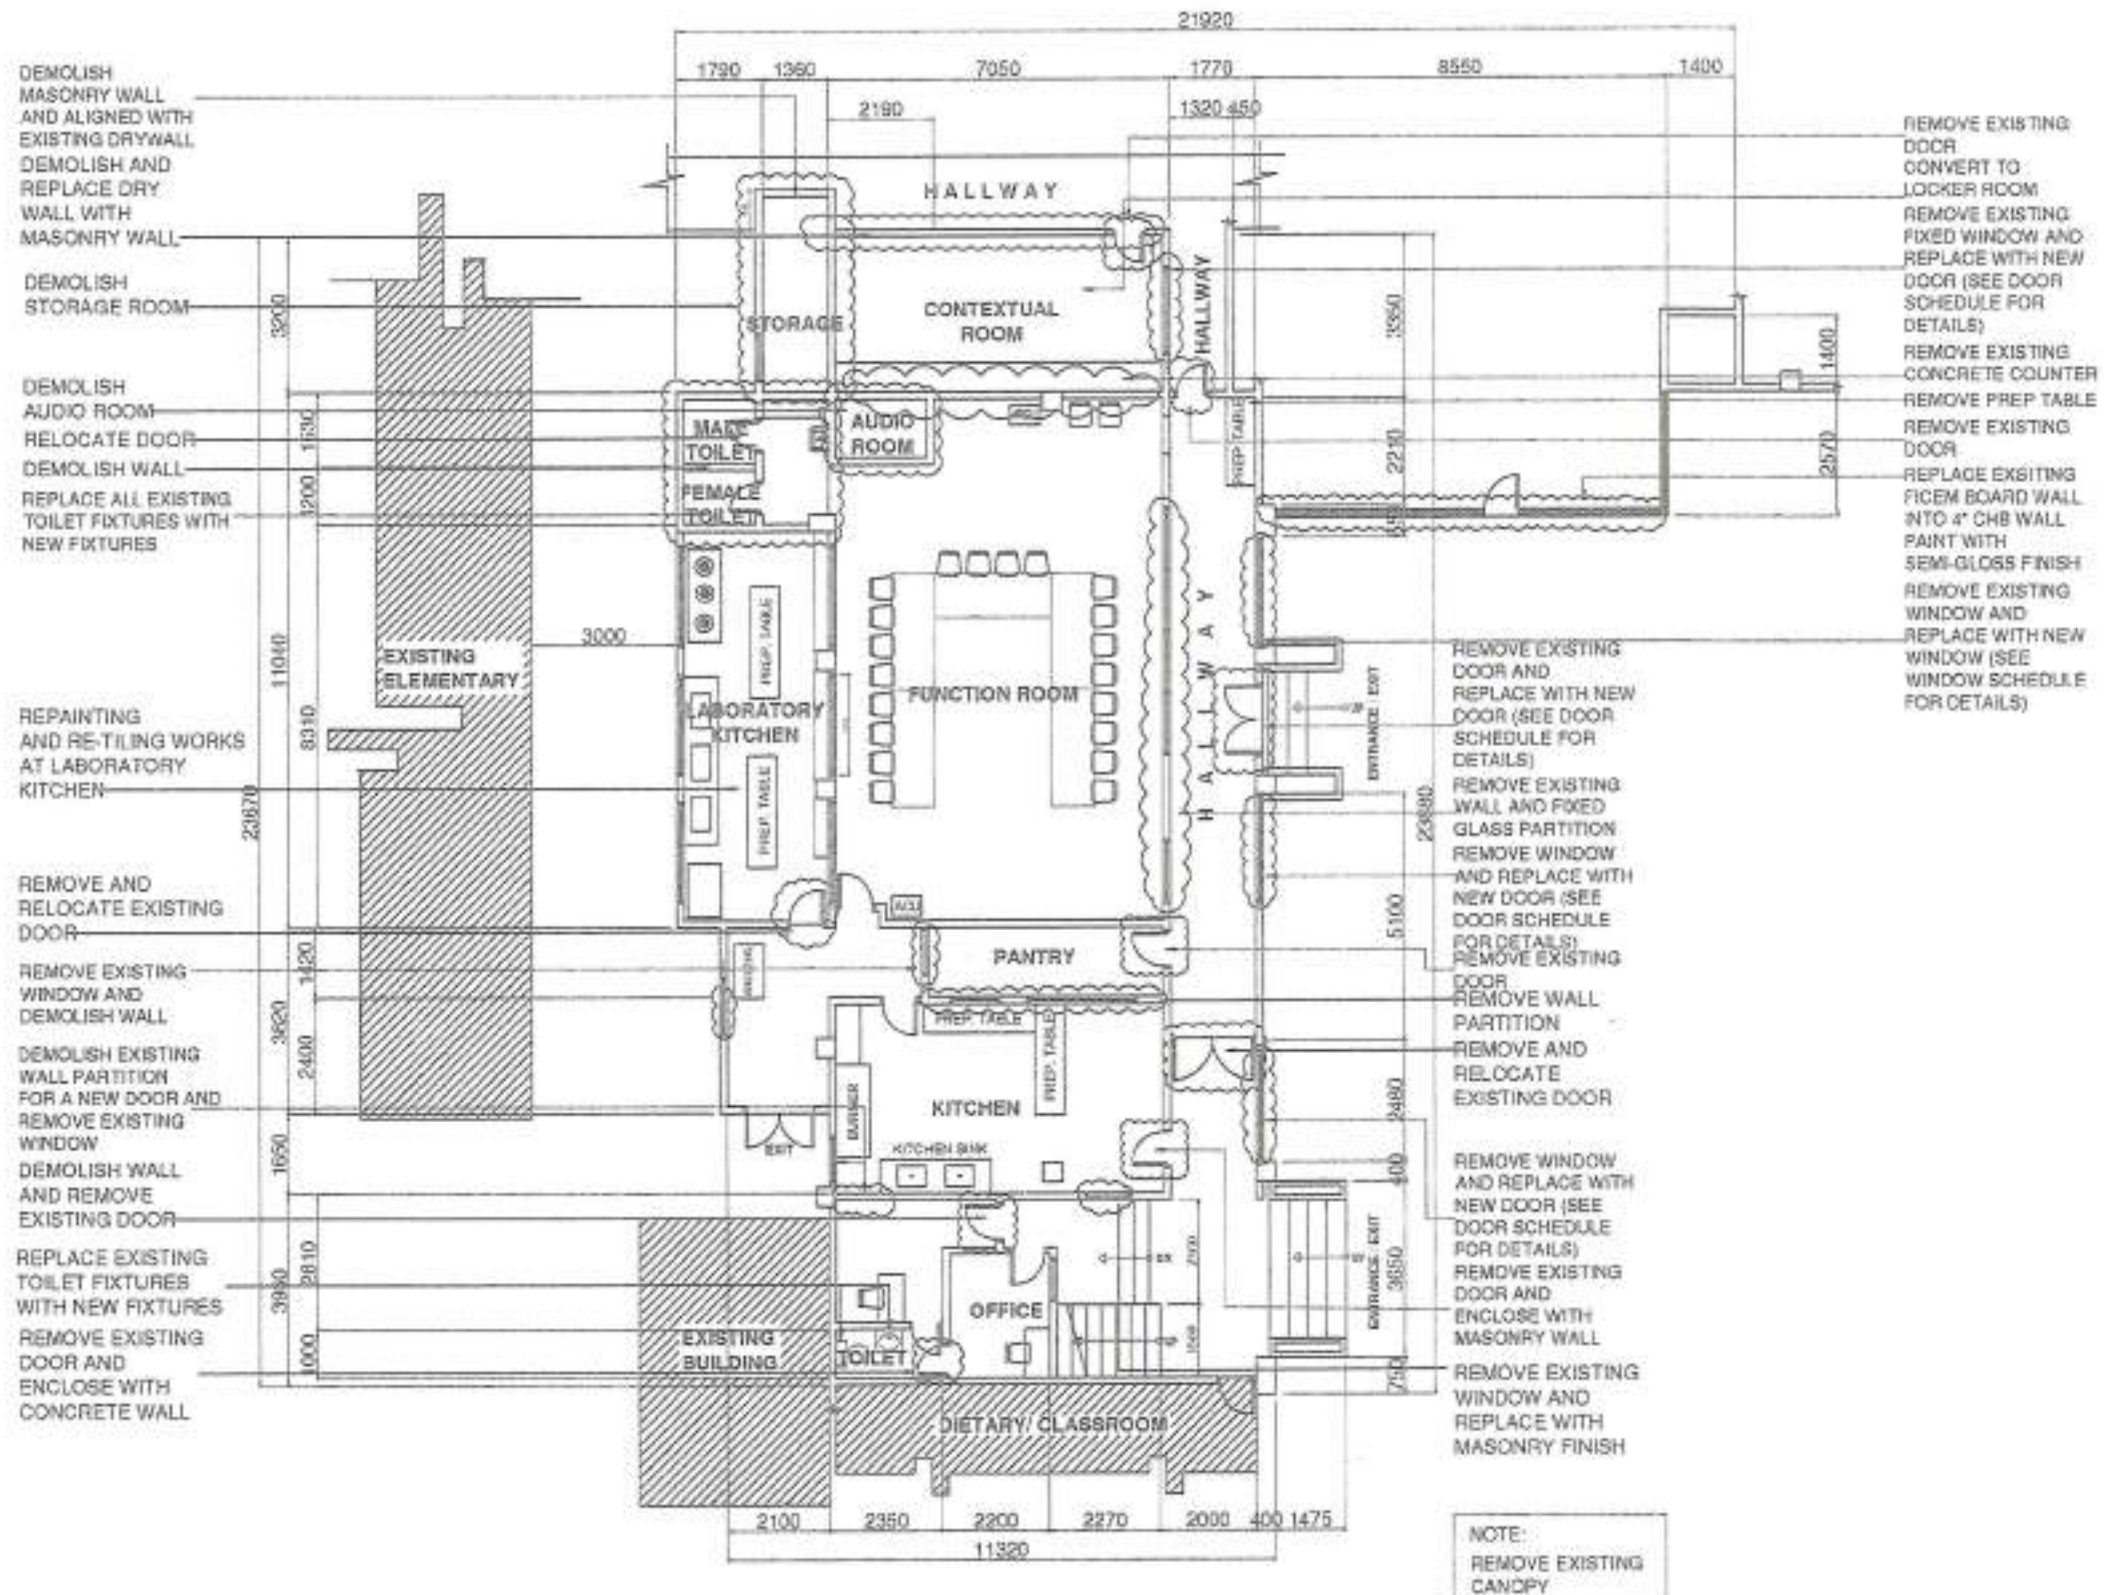

 **EXISTING PLAN OF CHE LABORATORY FUNCTION ROOM**
SCALE: 1:150MTRS


	DESIGNED BY: ARCH. JOSEPH ANDREW L. SAGALUAP UNIVERSITY ARCHITECT	PROJECT TITLE: RENOVATION OF COLLEGE OF HOME ECONOMICS LABORATORY, FUNCTION ROOM WITH PROVISION FOR FURNITURES AND FIXTURES	REQUISITIONER: DR. LUCIA M. SANTOS RND DEAN, COLLEGE OF HOME ECONOMICS	RECOMMENDING APPROVAL: ARCH. JOSEPH ANDREW L. SAGALUAP DIRECTOR OF PHYSICAL PLANT AND ENGINEERING SERVICES	RECOMMENDING APPROVAL: DR. JOSEPH D. MADRORAL VICE PRESIDENT FOR ADMIN AND FINANCE	APPROVED BY: DR. MA. CARLA A. OCHOTORENA VICE PRESIDENT	SHEET CONTENTS: DINING PLAN DRAWN BY: AIL HIGDO AIL HIGDO	SHEET NO: A02 02/36	
	PROJ: 0010577 PTR: 2029801 TEL: 445-010-028	LOCATION: WURU LOT 1, BALIWAN ZARANGA CITY		PROJ: 0010577 PTR: 2029801 TEL: 445-010-028					

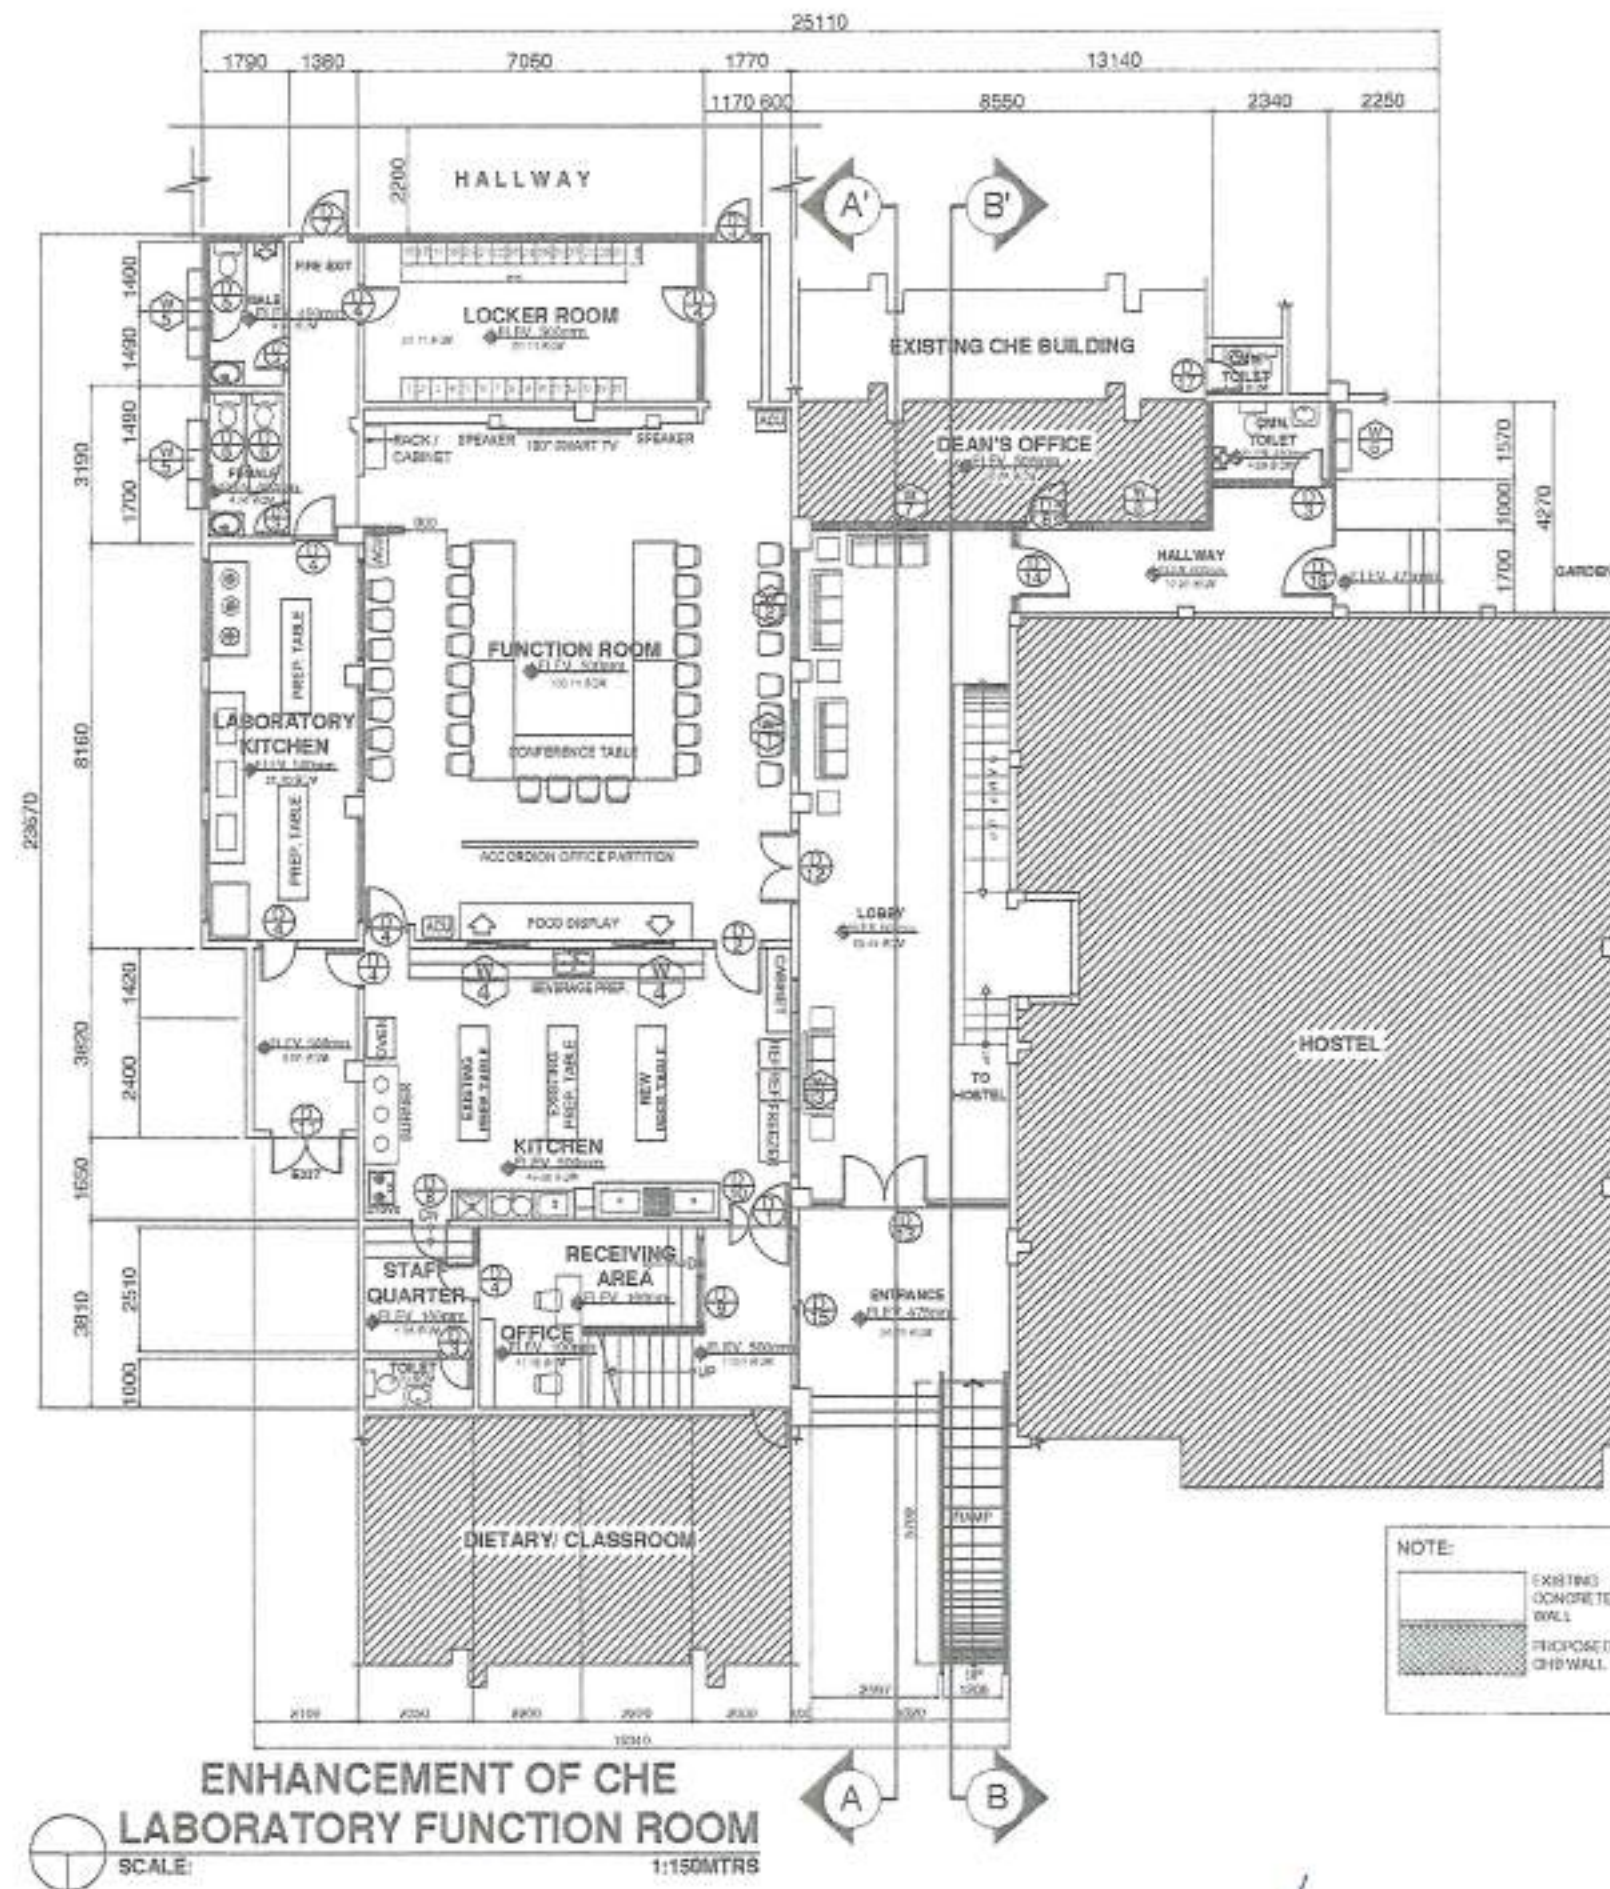


	DESIGNED BY: ARCH. JOSEPH ANDREW L. SAHIAL, UAP UNIVERSITY ARCHITECT PRG: 0010577 PTR: 2029291 TRN: 445-213-228	PROJECT TITLE: RENOVATION OF COLLEGE OF HOME ECONOMICS LABORATORY, FUNCTION ROOM WITH PROVISION FOR FURNITURES AND FIXTURES LOCATION: WARRI LOT 1 BALMORAN ZAMBOANGA CITY	REQUESTOR: DR. LUCIA M. SANTOS, RND LEARN COLLEGE OF HOME ECONOMICS	RECOMMENDING APPROVAL: ARCH. JOSEPH ANDREW L. SAHIAL, UAP DIRECTOR OF PHYSICAL PLANT AND ENGINEERING SERVICES PRG: 0010577 PTR: 2029291 TRN: 445-213-228	RECOMMENDING APPROVAL: DR. JOSELITO D. MADRONAL VICE PRESIDENT FOR ADMIN AND FINANCE	APPROVED BY: DR. MA. CARLA A. OCHOTORENA WARRI PRESIDENT	SHEET CONTENTS: RUMBLUM DRAFTED BY: AR. FREDO AR. RAMOSON	SHEET NO: A03 03/36	
--	--	---	---	---	--	--	--	---	--



FRONT ELEVATION
SCALE: 1:90mtrs

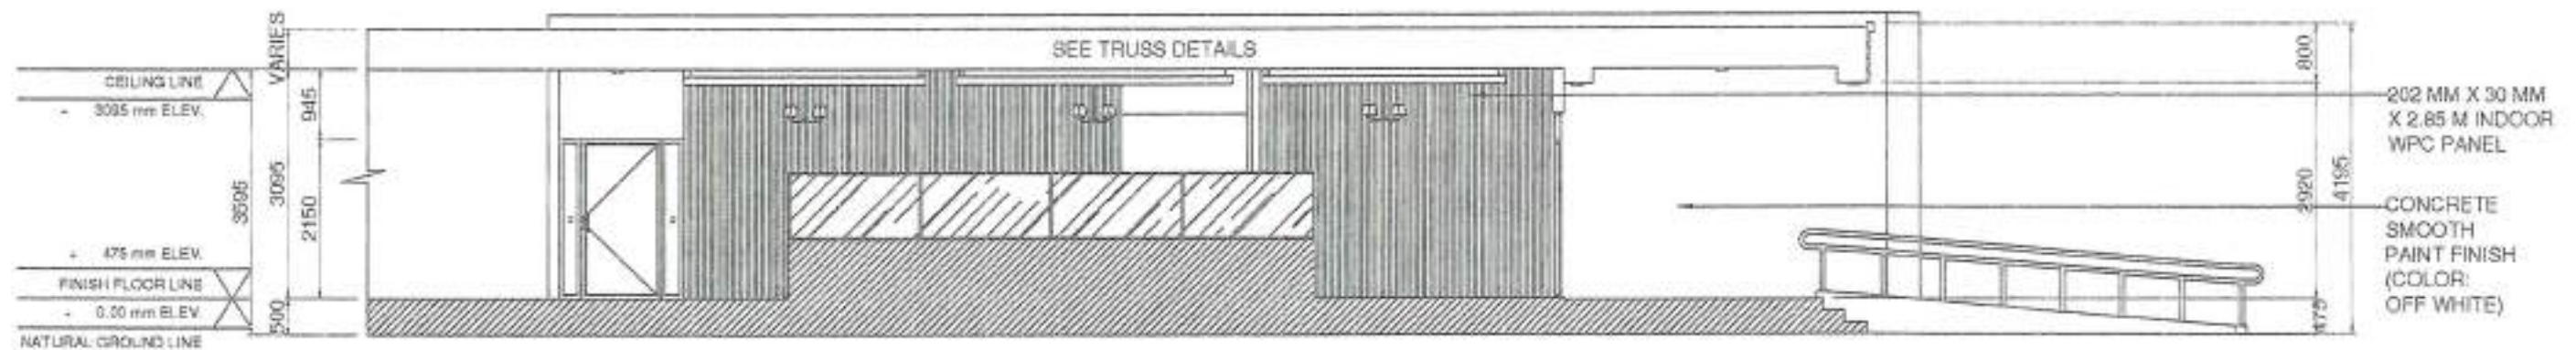

SECTION B-B'
SCALE: 1:90mtrs

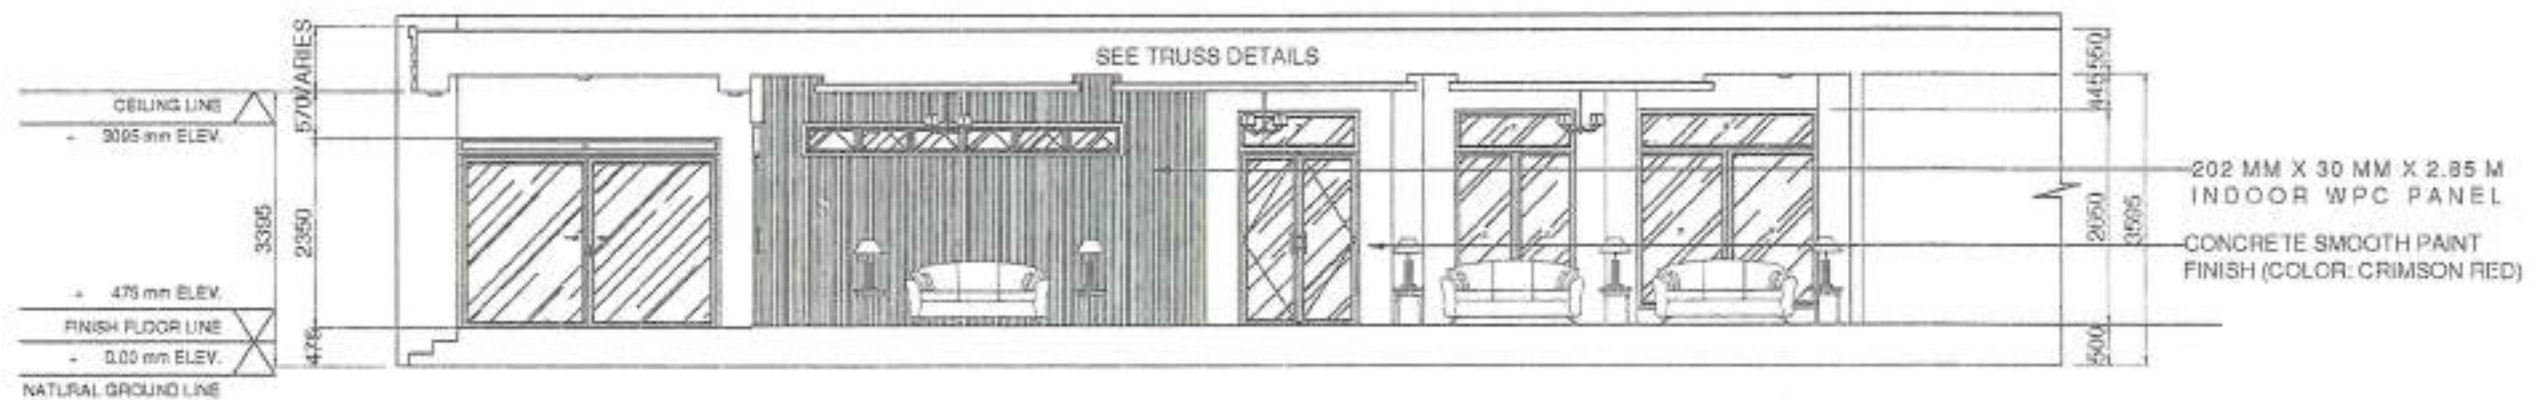

SECTION A-A'
SCALE: 1:90mtrs

	DESIGNED BY: ARCH. JOSEPH ANDREW L. SAHIAL, UAP UNIVERSITY ARCHITECT	PROJECT TITLE: RENOVATION OF COLLEGE OF HOME ECONOMICS LABORATORY, FUNCTION ROOM WITH PROVISION FOR FURNITURES AND FIXTURES	REGISTRATION: DR. LUCIA M. SANTOS, RMD DEAN, COLLEGE OF HOME ECONOMICS	RECOMMENDING APPROVAL: ARCH. JOSEPH ANDREW L. SAHIAL, UAP DIRECTOR OF PHYSICAL PLANT AND ENGINEERING SERVICES	RECOMMENDING APPROVAL: DR. JOBELITO C. MADROÑAL VICE PRESIDENT FOR ADMIN AND FINANCE	APPROVED BY: DR. MA. CARLA A. OCHOTORENA WUOL PRESIDENT	SHEET CONTENTS: FRONT ELEVATION SECTION QUANTITY ALL SHEETS ALL MATERIALS	SHEET NO. A04 0436	
--	--	--	--	---	--	---	--	---	--

2" x 4" POWDER COATED ALUMINUM FRAME W/ 6mm THK CLEAR GLASS 2" x 4" POWDER COATED ALUMINUM FRAME W/ 6mm THK CLEAR GLASS 2" x 4" POWDER COATED ALUMINUM FRAME W/ 6mm THK CLEAR GLASS	2" x 4" POWDER COATED ALUMINUM FRAME W/ 6mm THK CLEAR GLASS 2" x 4" POWDER COATED ALUMINUM FRAME W/ 6mm THK CLEAR GLASS 2" x 4" POWDER COATED ALUMINUM FRAME W/ 6mm THK CLEAR GLASS
1 SET	1 SET
HALLWAY	LOBBY ENTRANCE
DOUBLE GLASS DOOR WITH 2100mm x 4000mm THK CLEAR GLASS DOOR WITH 2" x 4" ALUMINUM FRAME	DOUBLE GLASS DOOR WITH 2" x 4" POWDER COATED ALUMINUM FRAME W/ COMPLETE LOCKSET AND ACCESSORIES

2" x 4" POWDER COATED ALUMINUM FRAME W/ 6mm THK CLEAR GLASS 2" x 4" POWDER COATED ALUMINUM FRAME W/ 6mm THK CLEAR GLASS 2" x 4" POWDER COATED ALUMINUM FRAME W/ 6mm THK CLEAR GLASS	2" x 4" POWDER COATED ALUMINUM FRAME W/ 6mm THK CLEAR GLASS 2" x 4" POWDER COATED ALUMINUM FRAME W/ 6mm THK CLEAR GLASS 2" x 4" POWDER COATED ALUMINUM FRAME W/ 6mm THK CLEAR GLASS
1 SET	1 SET
LOBBY LIFT	ENTRANCE TOILET
DOUBLE GLASS DOOR WITH 2100mm x 4000mm THK CLEAR GLASS DOOR WITH 2" x 4" ALUMINUM FRAME	DOUBLE GLASS DOOR WITH 2" x 4" POWDER COATED ALUMINUM FRAME W/ COMPLETE LOCKSET AND ACCESSORIES

SCHEDULE OF DOORS
SCALE: 1:100

2" x 4" POWDER COATED ALUMINUM FRAME W/ 6mm THK CLEAR GLASS 2" x 4" POWDER COATED ALUMINUM FRAME W/ 6mm THK CLEAR GLASS 2" x 4" POWDER COATED ALUMINUM FRAME W/ 6mm THK CLEAR GLASS	2" x 4" POWDER COATED ALUMINUM FRAME W/ 6mm THK CLEAR GLASS 2" x 4" POWDER COATED ALUMINUM FRAME W/ 6mm THK CLEAR GLASS 2" x 4" POWDER COATED ALUMINUM FRAME W/ 6mm THK CLEAR GLASS	2" x 4" POWDER COATED ALUMINUM FRAME W/ 6mm THK CLEAR GLASS 2" x 4" POWDER COATED ALUMINUM FRAME W/ 6mm THK CLEAR GLASS 2" x 4" POWDER COATED ALUMINUM FRAME W/ 6mm THK CLEAR GLASS	2" x 4" POWDER COATED ALUMINUM FRAME W/ 6mm THK CLEAR GLASS 2" x 4" POWDER COATED ALUMINUM FRAME W/ 6mm THK CLEAR GLASS 2" x 4" POWDER COATED ALUMINUM FRAME W/ 6mm THK CLEAR GLASS
1 SET	1 SET	1 SET	2 SETS
FUNCTION ROOM	FUNCTION ROOM	HALLWAY	KITCHEN TO FIXED DISPLAY
FIXED WINDOW WITH FIXED TRANSOM WINDOW INCLUDING 2" x 4" POWDER COATED ALUMINUM FRAME W/ COMPLETE ACCESSORIES	FIXED WINDOW WITH FIXED TRANSOM WINDOW INCLUDING 2" x 4" POWDER COATED ALUMINUM FRAME W/ COMPLETE ACCESSORIES	FIXED WINDOW WITH FIXED TRANSOM WINDOW INCLUDING 2" x 4" POWDER COATED ALUMINUM FRAME W/ COMPLETE ACCESSORIES	FIXED WINDOW WITH FIXED TRANSOM WINDOW INCLUDING 2" x 4" POWDER COATED ALUMINUM FRAME W/ COMPLETE ACCESSORIES

2" x 4" POWDER COATED ALUMINUM FRAME W/ 6mm THK CLEAR GLASS 2" x 4" POWDER COATED ALUMINUM FRAME W/ 6mm THK CLEAR GLASS 2" x 4" POWDER COATED ALUMINUM FRAME W/ 6mm THK CLEAR GLASS	2" x 4" POWDER COATED ALUMINUM FRAME W/ 6mm THK CLEAR GLASS 2" x 4" POWDER COATED ALUMINUM FRAME W/ 6mm THK CLEAR GLASS 2" x 4" POWDER COATED ALUMINUM FRAME W/ 6mm THK CLEAR GLASS	2" x 4" POWDER COATED ALUMINUM FRAME W/ 6mm THK CLEAR GLASS 2" x 4" POWDER COATED ALUMINUM FRAME W/ 6mm THK CLEAR GLASS 2" x 4" POWDER COATED ALUMINUM FRAME W/ 6mm THK CLEAR GLASS	2" x 4" POWDER COATED ALUMINUM FRAME W/ 6mm THK CLEAR GLASS 2" x 4" POWDER COATED ALUMINUM FRAME W/ 6mm THK CLEAR GLASS 2" x 4" POWDER COATED ALUMINUM FRAME W/ 6mm THK CLEAR GLASS
2 SETS	1 SET	1 SET	1 SET
MALE AND FEMALE TOILET	COMMON TOILET	DEANS OFFICE	DEANS OFFICE
FIXED WINDOW WITH FIXED TRANSOM WINDOW INCLUDING 2" x 4" POWDER COATED ALUMINUM FRAME W/ COMPLETE ACCESSORIES	FIXED WINDOW WITH FIXED TRANSOM WINDOW INCLUDING 2" x 4" POWDER COATED ALUMINUM FRAME W/ COMPLETE ACCESSORIES	FIXED WINDOW WITH FIXED TRANSOM WINDOW INCLUDING 2" x 4" POWDER COATED ALUMINUM FRAME W/ COMPLETE ACCESSORIES	FIXED WINDOW WITH FIXED TRANSOM WINDOW INCLUDING 2" x 4" POWDER COATED ALUMINUM FRAME W/ COMPLETE ACCESSORIES

SCHEDULE OF WINDOWS
SCALE: 1:100



	DESIGNED BY	PROJECT TITLE	REQUESTOR	RECOMMENDING APPROVAL		RECOMMENDING APPROVAL	APPROVED BY	SHEET CONTENTS	SHEET NO.	
	ARCH. JOSEPH ANDREW L. BAHIAL, UAP UNIVERSITY ARCHITECT	RENOVATION OF COLLEGE OF HOME ECONOMICS LABORATORY, FUNCTION ROOM WITH PROVISION FOR FURNITURES AND FIXTURES	DR. LUCIA M. SANTOS, RND DEAN, COLLEGE OF HOME ECONOMICS	ARCH. JOSEPH ANDREW L. BAHIAL, UAP DIRECTOR OF PHYSICAL PLANT AND MAINTENANCE SERVICES	DR. JOSE LITO D. MADRORAL VICE PRESIDENT FOR ADMIN AND FINANCE	DR. MA. CARLA A. OCHOTORENA UNIVERSITY PRESIDENT	0010577, 269884	A06 06/36		
PRC: 0010577	PTR: 269884	TNL: 443-010-226	LOCATION: MISBLOT 1, BALINRANG ZAMBANGA CITY	PRC: 0010577	PTR: 269884	TNL: 443-010-226	DRAPED BY: DR. RUELLO AG. SANCION			

NOTE
MATTE STAINLESS STEEL 304 LETTERINGS ANCHORED TO THE CONCRETE WALL (TO ARCHITECT'S APPROVAL)



104 85 90 90 83 117 85 105 98 117 105
116 85 111 116 97 117 80 116 117 24 98
152
COLLEGE OF HOME ECONOMICS

85 99 99 120 99 87
96 108 25 85 131 87
152
FUNCTION HALL
ELEVATION SIDE ELEVATION


BUILT-UP SIGNAGE DETAIL
SCALE: 1:30MTRS

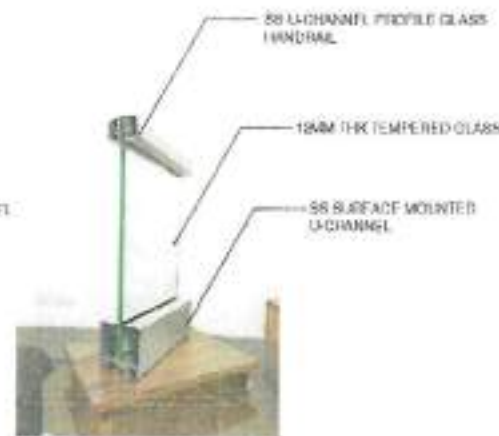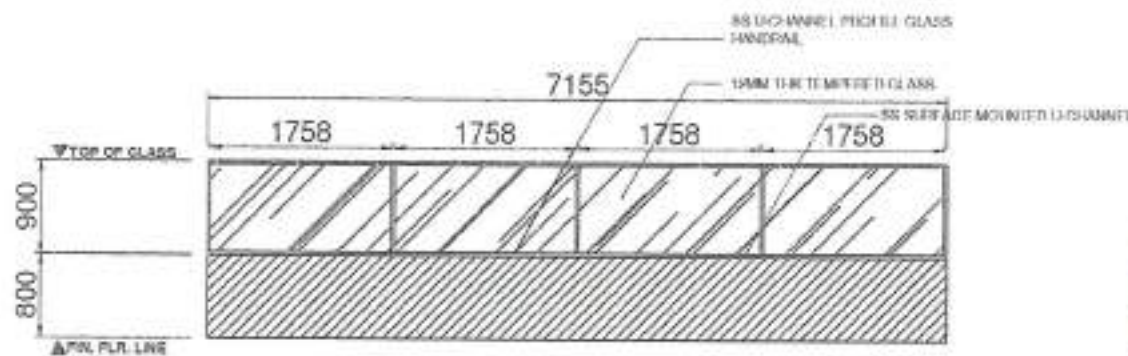

GLASS RAILINGS LEFT SIDE DETAIL
SCALE: 1:70MTRS

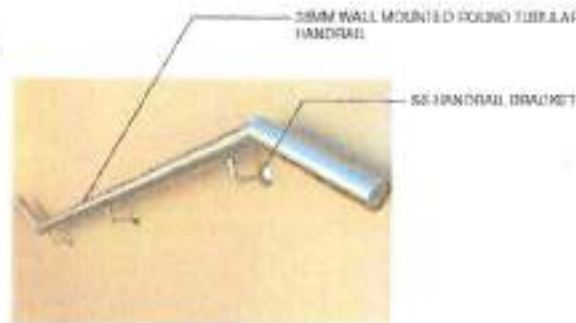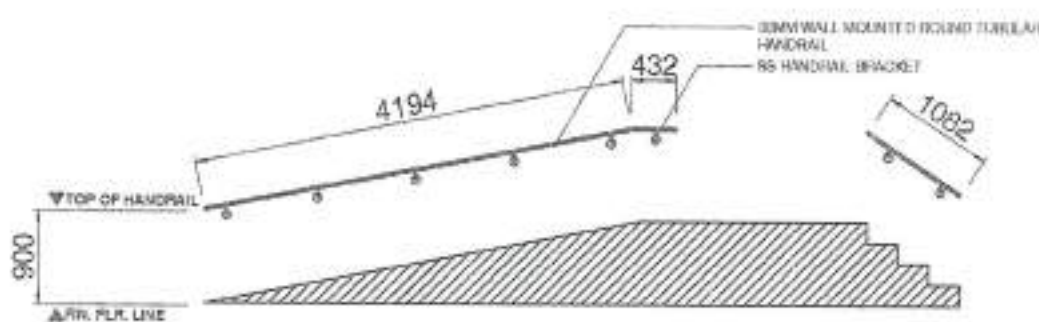


GLASS RAILINGS LONGITUDINAL SECTION
SCALE: 1:70MTRS

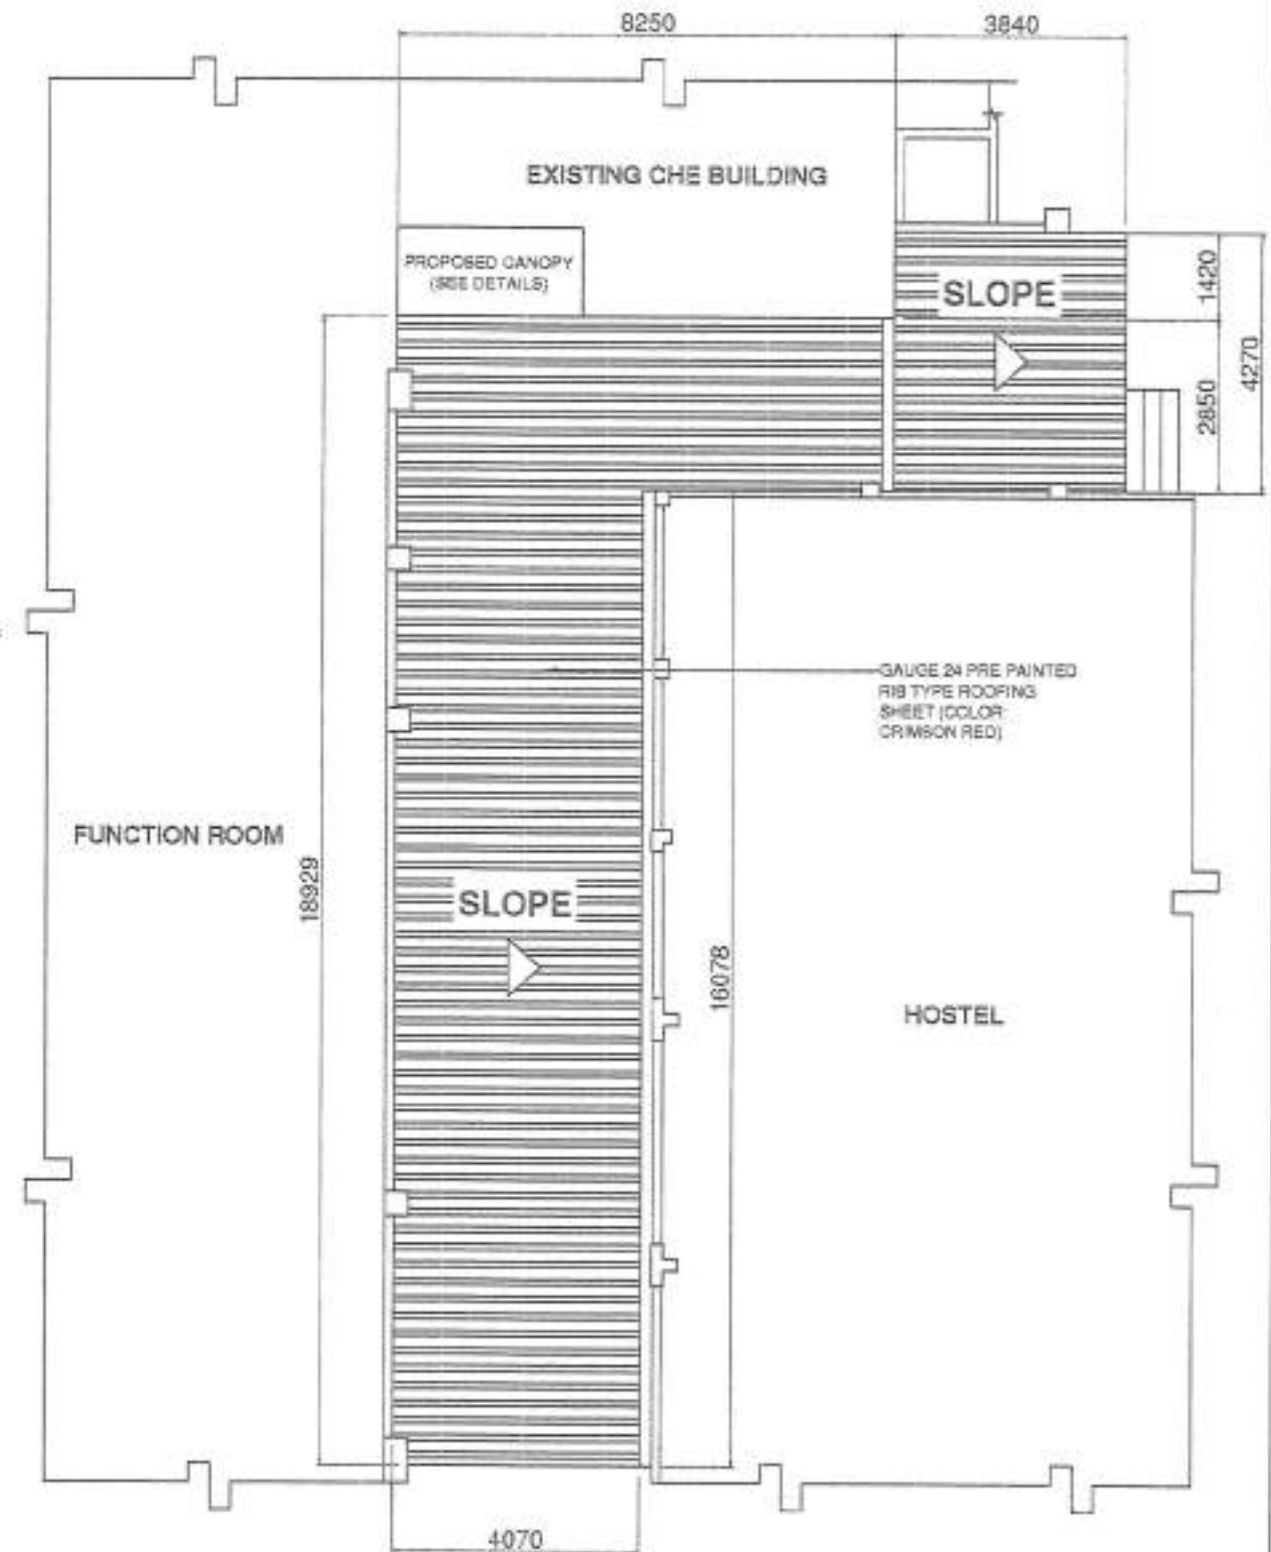


ROOF PLAN
SCALE: 1:150MTRS

	DESIGNED BY: ARCH. JOSEPH ANDREW L. SAHIAL, UAP UNIVERSITY ARCHITECT	PROJECT TITLE: RENOVATION OF COLLEGE OF HOME ECONOMICS LABORATORY, FUNCTION ROOM WITH PROVISION FOR FURNITURES AND FIXTURES	REQUISITIONER: DR. LUCIA M. SANTOS, RND DEAN, COLLEGE OF HOME ECONOMICS	RECOMMENDING APPROVAL: ARCH. JOSEPH ANDREW L. SAHIAL, UAP DIRECTOR OF PHYSICAL PLANT AND ENGINEERING SERVICES	RECOMMENDING APPROVAL: DR. JOSEPH O. MADROAL VICE PRESIDENT FOR ADMIN AND FINANCE	APPROVED BY: DR. MA. CARLA A. OCHOTORENA VICE PRESIDENT	SHEET CONTENTS: MULTI-PHASED ROOF PLAN	SHEET NO.: A07 07/36	
	PRJ: 0010577 PIR: 268281 TEL: 445-015-238	LOCATION: WURJ LOT 1, SALMONDA 2280, SALMONDA CITY		PRJ: 0010577 PIR: 268281 TEL: 445-015-238					

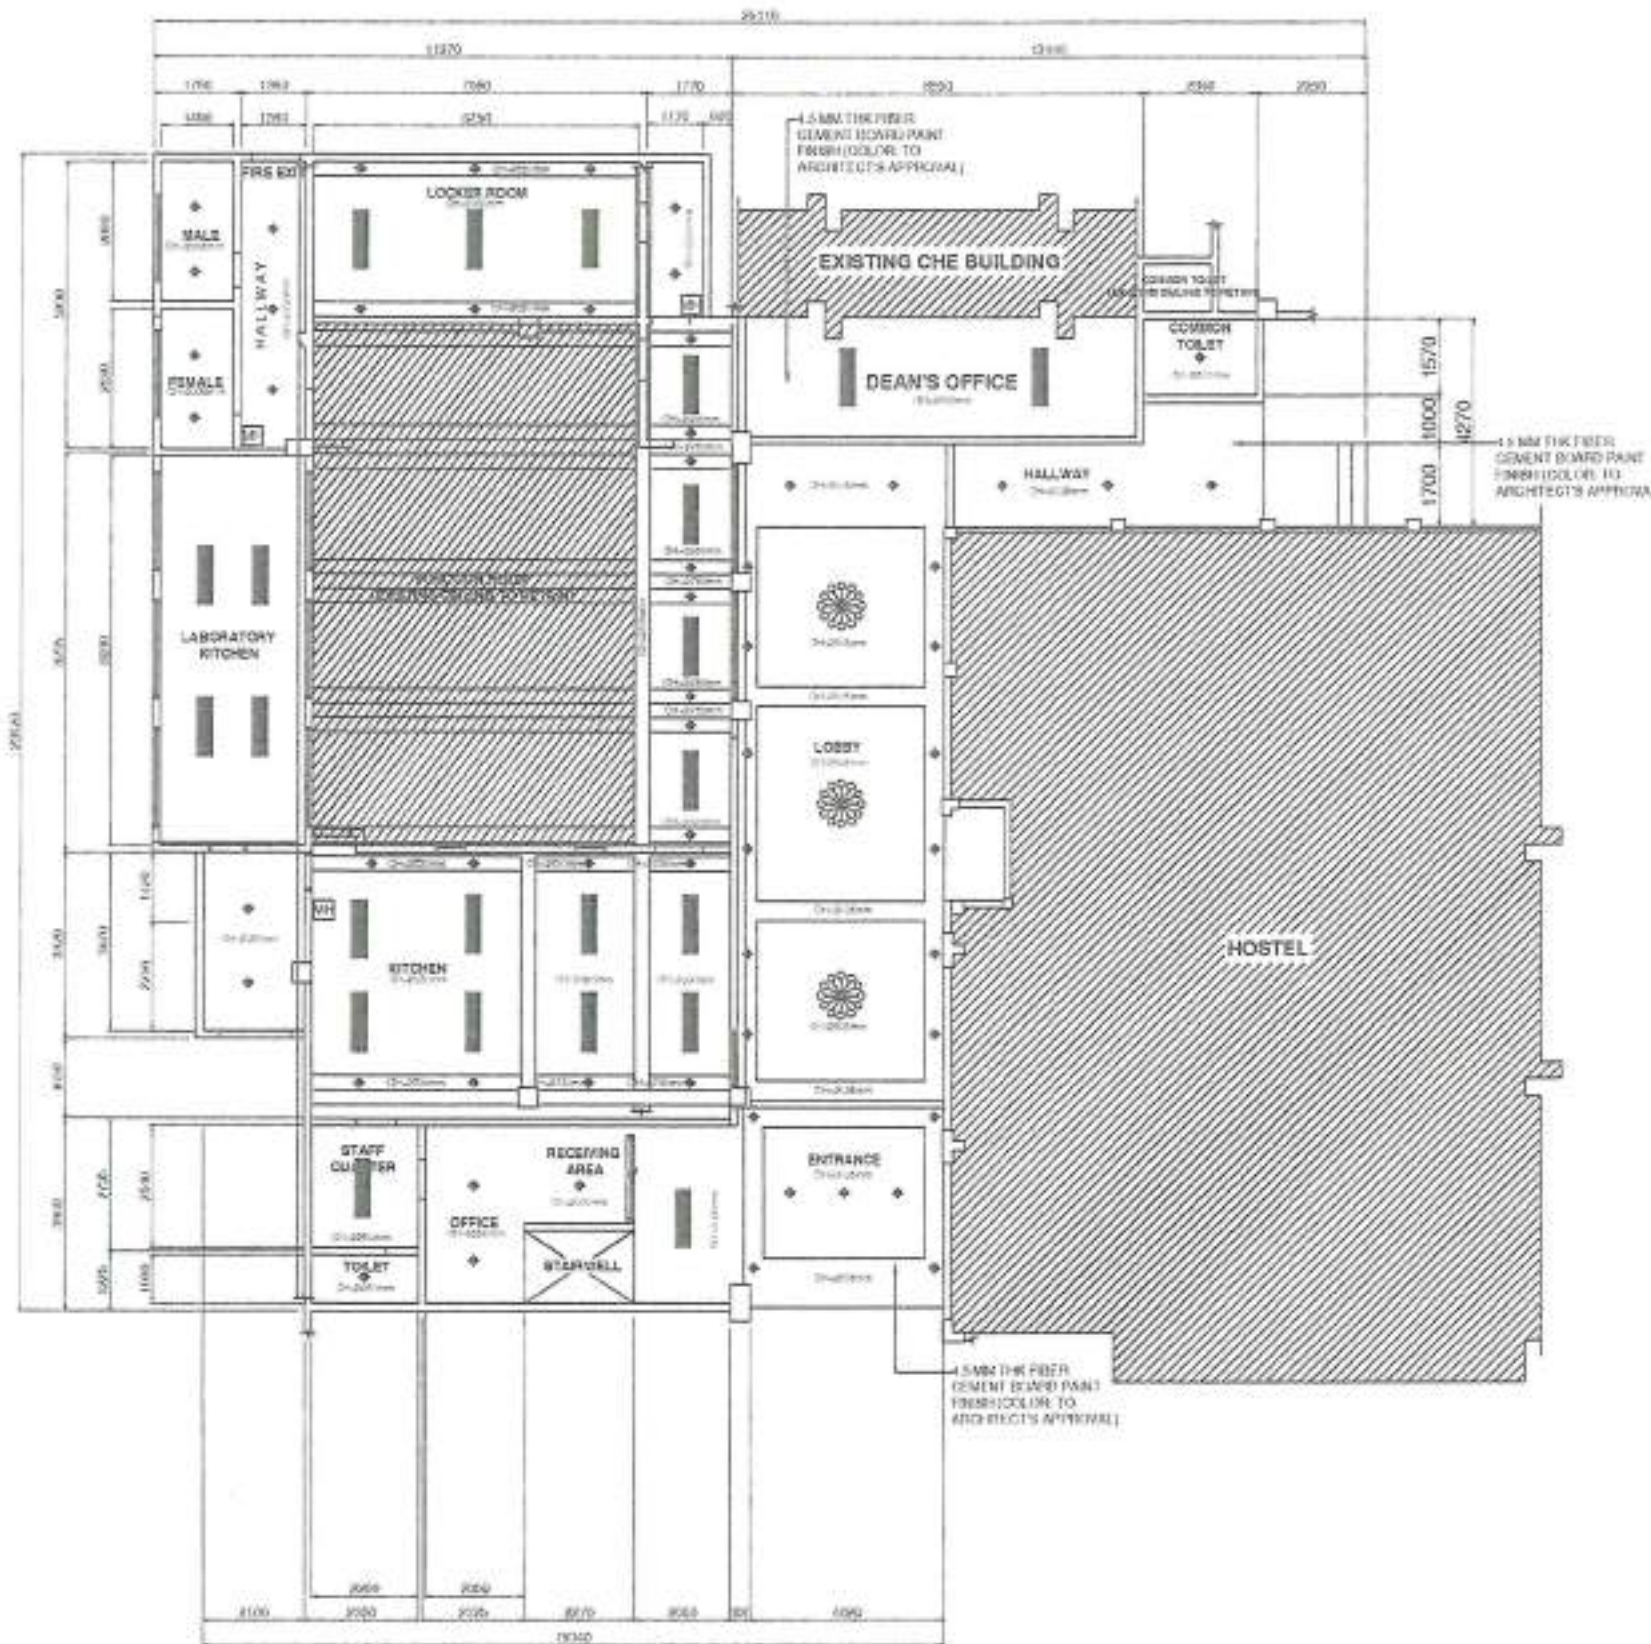

GROUND FLOOR REFLECTED CEILING PLAN
SCALE 1:1000

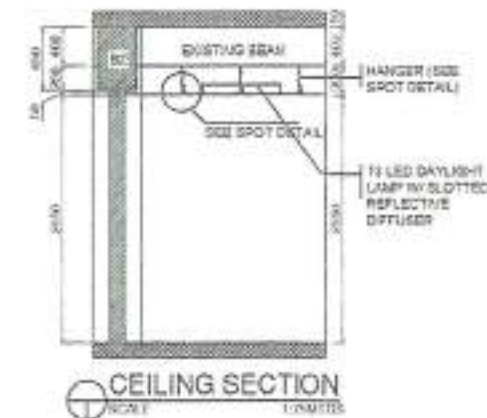

LEGEND:

PL	PANELS
TL	TUBULAR LAMP W/ REFLECTIVE DIFFUSER
LM	600mm X 600mm MANHOLE
SL	STREP LIGHT
PL	PENDANT LIGHT
CH	CHANDELIER

GENERAL NOTES:



- BEFORE LAYING OUT THE CEILING FRAMING, COORDINATE WITH THE PHYSICAL PLANT AND ENGINEERING SERVICES (ARCHITECTS).
- CHECK THE ELEVATION OF THE ENTIRE CORNER CEILING LEVEL.
- ANCHOR OR WELD OLD CEILING HANGER TO THE CHAIRS OF THE HOOT.
- WITH A 10MM X 10MM THREADED ROD AT THE END OF THE ROD WITH A BOLT AND WASHER, USE A 10MM PLAN ROUND BAR TO BE EXTEND AND WELD TO THE CHAIRS FOR THE CEILING FRAMING.
- USE 0.8mm THICK X 10MM X 60MM DOUBLE FLIPPING SPACE (80MM X 60MM) ON CENTRE FOR ALL CEILING FRAMING.
- USE 0.8mm THICK X 10MM X 35MM CHANNEL FOR ALL CARRYING CHANNEL WITH COMPLETE ACCESSORIES SUCH W/OUT WIRE CLIP OR JCLIP.
- USE 25MM X 25MM WALL ANGLE FOR ALL CORNER SUPPORT.
- USE 2.0MM THICK X 1/2" X 1/2" FRESH CEMENT BOARD.



NOTE: 800MM X 800MM ALUMINUM ALLOY FRAME WITH G.I. COVER WITH COMPLETE ACCESSORIES


CEILING MANHOLE COVER
SCALE 1:1000

	DESIGNED BY:	PROJECT TITLE:	REQUESTOR:	RECOMMENDING APPROVAL:	RECOMMENDING APPROVAL:	APPROVED BY:	SHEET CONTENTS:	SHEET NO.:	
	ARCH. JOSEPH ANDREW L. SAHAL, UAP UNIVERSITY ARCHITECT	RENOVATION OF COLLEGE OF HOME ECONOMICS LABORATORY, FUNCTION ROOM WITH PROVISION FOR FURNITURES AND FIXTURES	DR. LUCIA M. SANTOS, RND DEAN, COLLEGE OF HOME ECONOMICS	ARCH. JOSEPH ANDREW L. SAHAL, UAP DIRECTOR OF PHYSICAL PLANT AND ENGINEERING SERVICES	DR. JOBELITO D. MADRONAL VICE PRESIDENT FOR ADMIN AND FINANCE	DR. MA. CARLA A. OCHOTORENA VICE PRESIDENT	REFLECTED CEILING PLAN CEILING DETAILS	A08 08/36	
	PRC: 0010677 PPS: 222601 FW: 445-013-228	LOCATION: WVRU LOT 1, BALIWAN, ZAMBANGA CITY		PRC: 0010677 PPS: 209051 TEL: 445-013-228			DRAWN BY: AR, REISO AR, SANCHEZ		

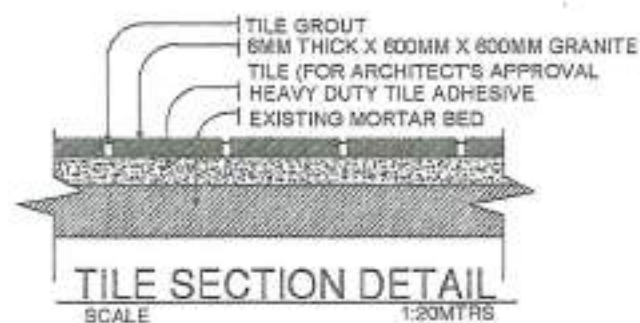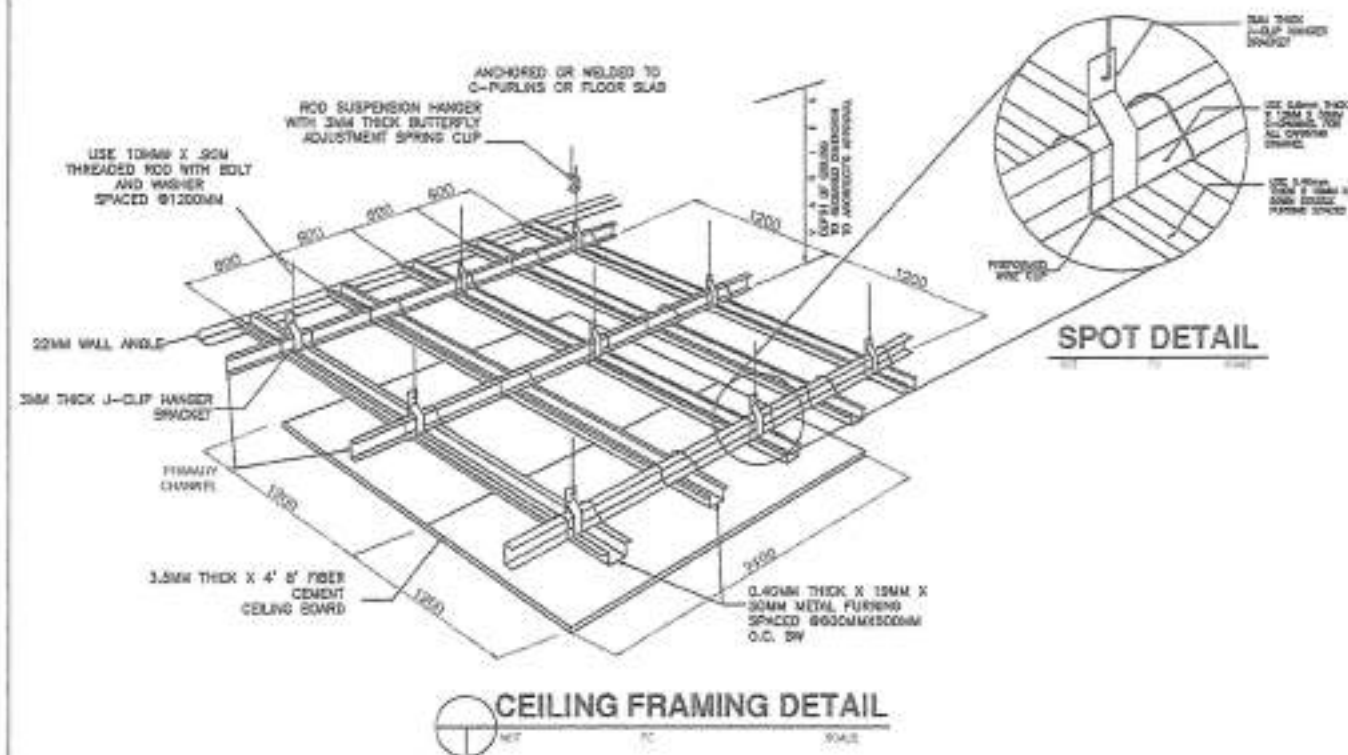

GENERAL NOTES:

- ALL FLOOR TILES ARE LABELED BASED ONLY ON TEXTURE.
- COLOR AND OTHER VARIETIES OF TILES ARE SUBJECT FOR APPROVAL OF THE PHYSICAL PLANT AND ENGINEERING SERVICES DIRECTOR
- FOR GROUND FLOOR AREA, USE STANDARD TILE ADHESIVE (HEAVY DUTY)

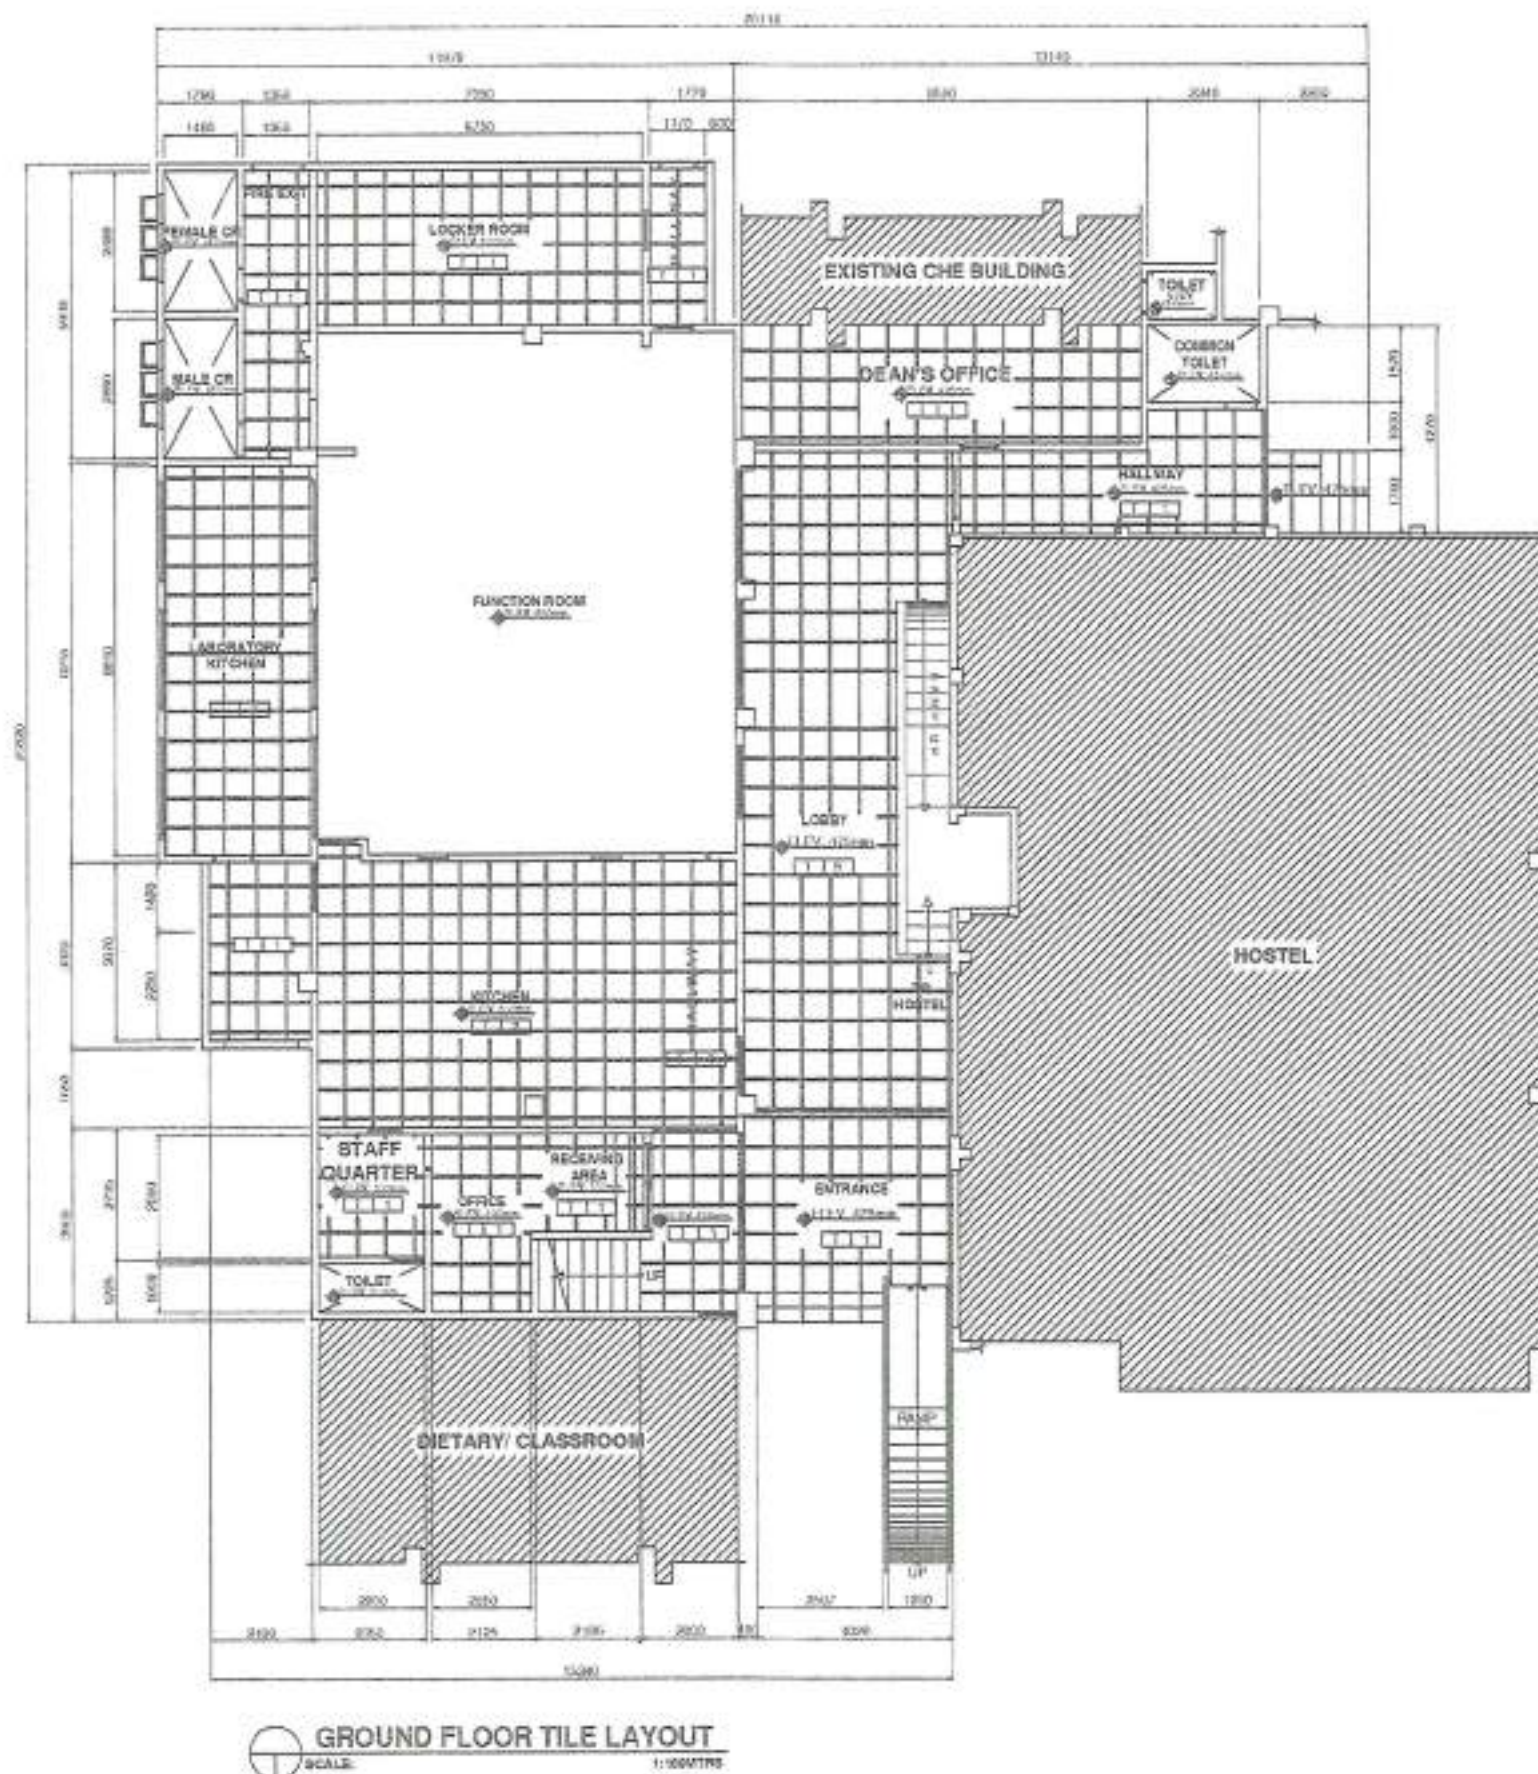

	DESIGNED BY: ARCH. JOSEPH ANDREW L. SAHAL, UAP UNIVERSITY ARCHITECT PRC: 001677 PTR: 288801 TRN: 445-013-288	PROJECT TITLE: RENOVATION OF COLLEGE OF HOME ECONOMICS LABORATORY, FUNCTION ROOM WITH PROVISION FOR FURNITURES AND FIXTURES LOCATION: MARILLOT 1, DALANGAN 2ND DIVISION CITY	REQUESTOR: DR. LUCIA M. SANTOS, RND DEAN, COLLEGE OF HOME ECONOMICS	RECOMMENDING APPROVAL: ARCH. JOSEPH ANDREW L. SAHAL, UAP DIRECTOR OF PHYSICAL PLANT AND ENGINEERING SERVICES PRC: 001677 PTR: 288801 TRN: 445-013-288	RECOMMENDING APPROVAL: DR. JOELITO D. MADROAL VICE PRESIDENT FOR ADMIN AND FINANCE	APPROVED BY: DR. MA. CARLA A. OCHOTORENA WUVP PRESIDENT	SHEET CONTENTS: CEILING FRAMING DETAIL GROUND FLOOR TILE LAYOUT DESIGNED BY: ARCH. JOSEPH ANDREW L. SAHAL, UAP	SHEET NO. A09 09/36	
--	---	---	---	--	--	---	--	--	--

LEGEND:


- 1. 6mm x 600mm x 600mm CERAMIC UNGLAZED FLOOR TILE
- 2. 6mm x 600mm x 600mm NON-SLIP CERAMIC FLOOR TILE
- 3. 6mm THK x 600mm x 600mm WHITE PORCELAIN TILES WITH FLEXIBLE CEMENTITIOUS WATERPROOFING AND THIN-BET MORTAR ADHESIVE (COLOR FOR ARCHITECT'S APPROVAL)
- 4. 6mm THK x 300mm x 600mm GLOSSY PORCELAIN WALL TILES (COLOR ARCHITECT'S APPROVAL)
- 5. 6mm x 600mm x 600mm CERAMIC GLAZED FLOOR TILE

NOTE:


- ALL 300mm x 600mm WALL AND 600mm x 600mm FLOOR TILES ARE SUBJECT FOR ARCHITECT'S APPROVAL.
- FLOOR SHALL BE WITH 1% SLOPE TO FLOOR DRAIN.
- ALL FIXTURES AND OTHER TOILET ACCESSORIES ARE SUBJECT FOR APPROVAL OF THE UNIVERSITY ARCHITECT.

LEGEND:


- 1. 6mm THK x 600mm x 600mm WHITE PORCELAIN TILES WITH FLEXIBLE CEMENTITIOUS WATERPROOFING AND THIN-BET MORTAR ADHESIVE (COLOR FOR ARCHITECT'S APPROVAL)
- 2. 6mm THK x 300mm x 600mm GLOSSY PORCELAIN WALL TILES (COLOR ARCHITECT'S APPROVAL)

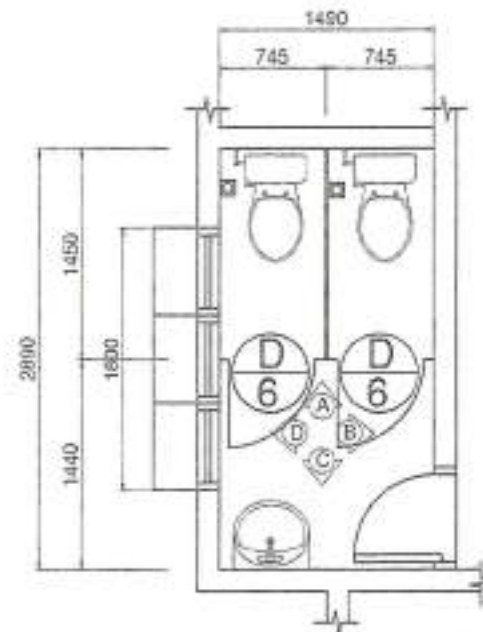

FEMALE CR PLAN
SCALE: 1:50 mtrs

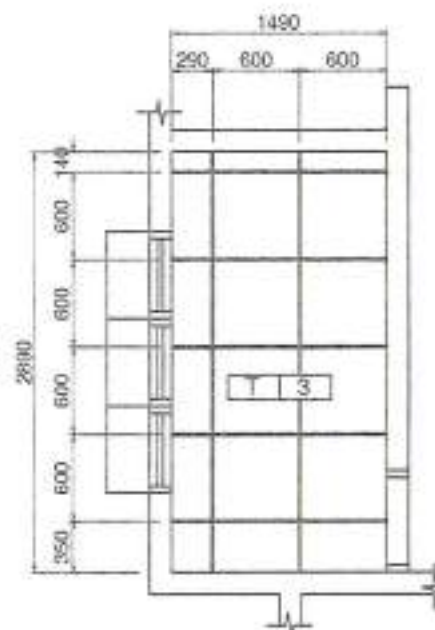


TILE LAYOUT
SCALE: 1:50 mtrs

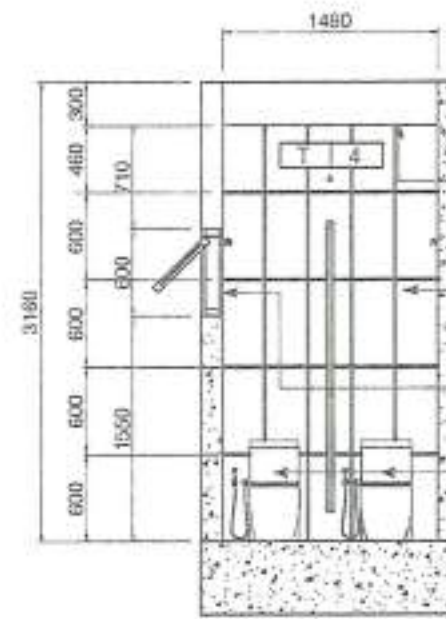


INTERIOR SECTION A
SCALE: 1:50 mtrs



INTERIOR SECTION C
SCALE: 1:50 mtrs

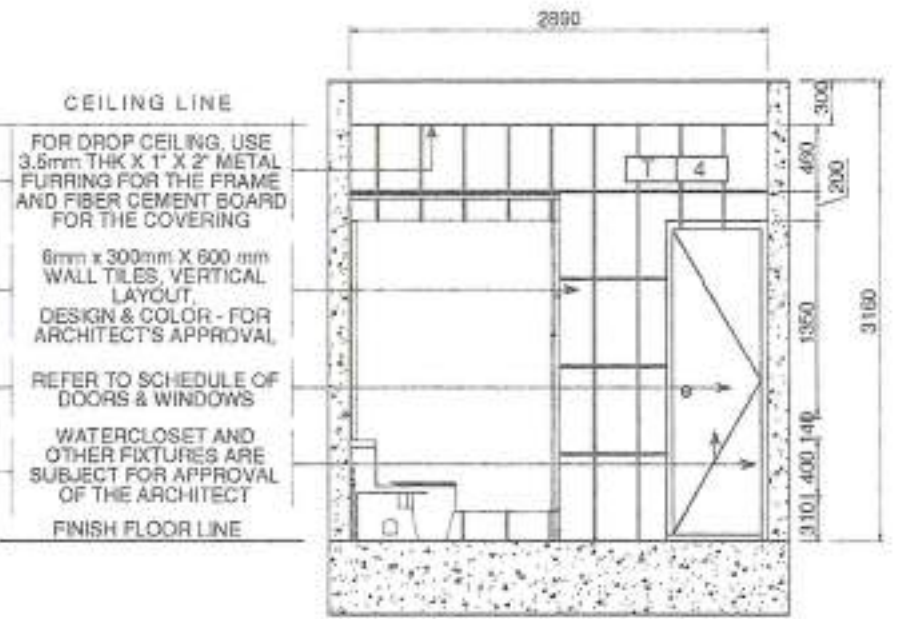

INTERIOR SECTION B
SCALE: 1:50 mtrs

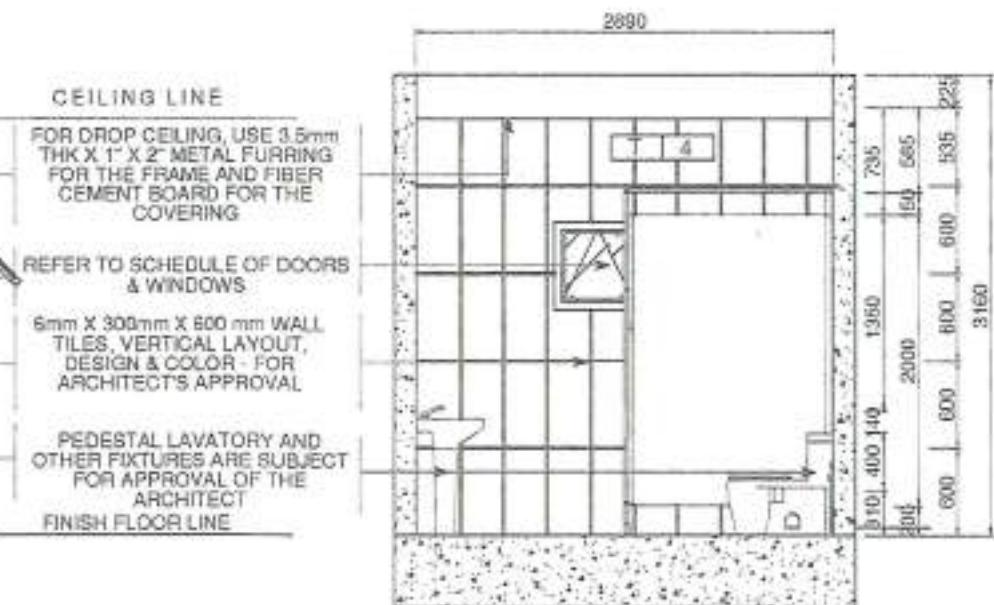

INTERIOR SECTION D
SCALE: 1:50 mtrs

	DESIGNED BY: ARCH. JOSEPH ANDREW L. SAHIALUAP UNIVERSITY ARCHITECT	PROJECT TITLE: RENOVATION OF COLLEGE OF HOME ECONOMICS LABORATORY, FUNCTION ROOM WITH PROVISION FOR FURNITURES AND FIXTURES	REQUESTOR: DR. LUCIA M. SANTOS, PhD DEAN, COLLEGE OF HOME ECONOMICS	RECOMMENDING APPROVAL: ARCH. JOSEPH ANDREW L. SAHIALUAP DIRECTOR OF PHYSICAL PLANT AND ENGINEERING SERVICES	RECOMMENDING APPROVAL: DR. JOSE L. D. MACARAOG VICE PRESIDENT FOR ADMIN AND FINANCE	APPROVED BY: DR. MA. CARLA A. OCHOTORENA VICE PRESIDENT	SHEET CONTENTS: GROUND FLOOR TILE LAYOUT FEMALE CR PLAN TILE LAYOUT INTERIOR SECTION A AND B INTERIOR SECTION C INTERIOR SECTION D DRAWN BY: AR. REED ALL DIMENSIONS	SHEET NO. A10 10/36
--	--	--	---	--	--	---	---	--



MALE CR PLAN
SCALE: 1:50 mtrs




INTERIOR SECTION A
SCALE: 1:50 mtrs

FOR DROP CEILING, USE 3.5mm THK X 1" X 2" METAL FURRING FOR THE FRAME AND FIBER CEMENT BOARD FOR THE COVERING


6mm X 300mm X 600 mm WALL TILES, VERTICAL LAYOUT, DESIGN & COLOR - FOR ARCHITECT'S APPROVAL

REFER TO SCHEDULE OF DOORS & WINDOWS


WATERCLOSET AND OTHER FIXTURES ARE SUBJECT FOR APPROVAL OF THE ARCHITECT

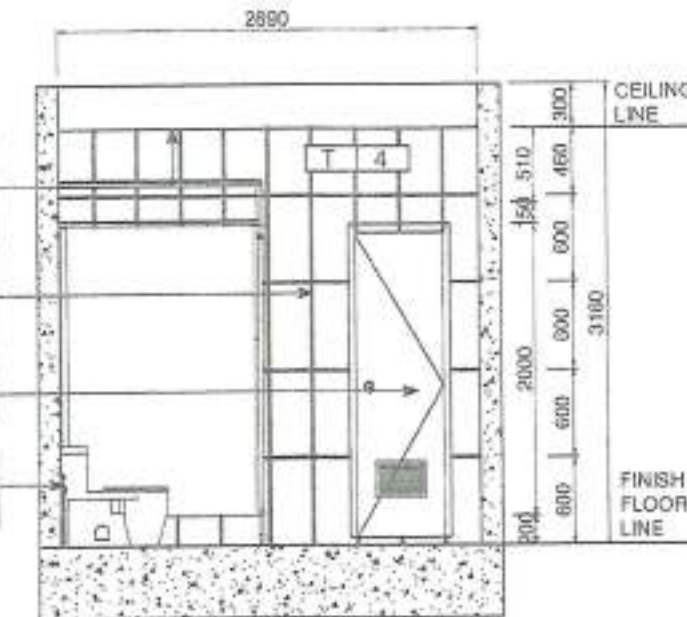

INTERIOR SECTION B
SCALE: 1:50 mtrs

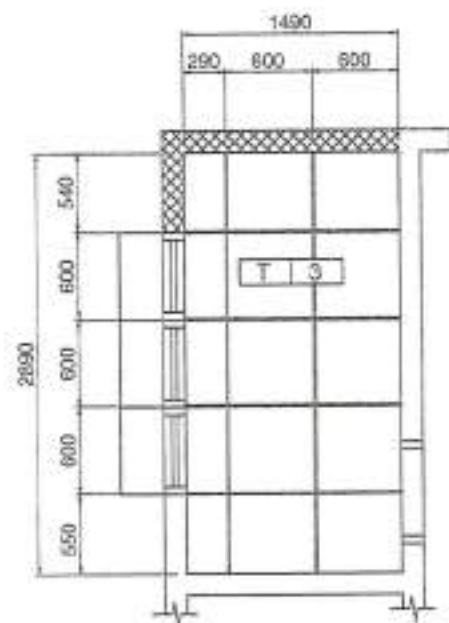

TILE LAYOUT
SCALE: 1:50 mtrs

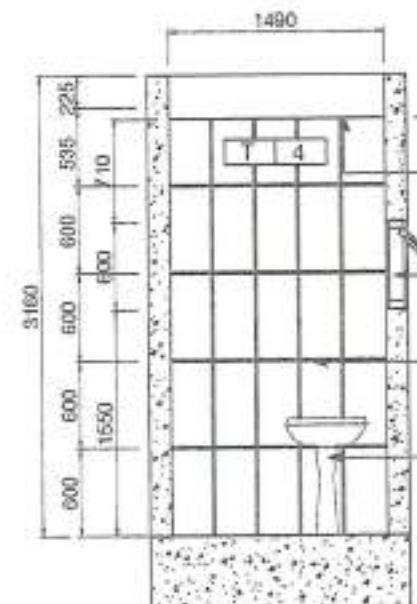

INTERIOR SECTION C
SCALE: 1:50 mtrs

CEILING LINE


FOR DROP CEILING, USE 3.5mm THK X 1" X 2" METAL FURRING FOR THE FRAME AND FIBER CEMENT BOARD FOR THE COVERING

REFER TO SCHEDULE OF DOORS & WINDOWS

6mm X 300mm X 600 mm WALL TILES, VERTICAL LAYOUT, DESIGN & COLOR - FOR ARCHITECT'S APPROVAL

PEDESTAL LAVATORY AND OTHER FIXTURES ARE SUBJECT FOR APPROVAL OF THE ARCHITECT



FINISH FLOOR LINE

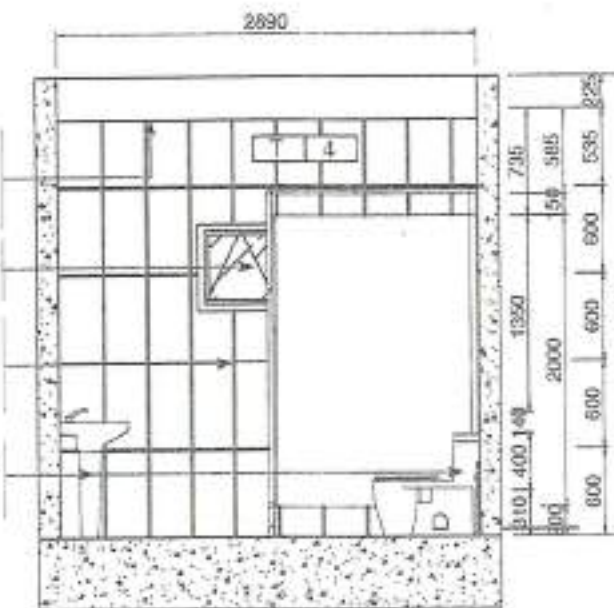



INTERIOR SECTION D
SCALE: 1:50 mtrs



DESIGNED BY: ARCH. JOSEPH ANDREW L. SAHALUAP UNIVERSITY ARCHITECT	PROJECT TITLE: RENOVATION OF COLLEGE OF HOME ECONOMICS LABORATORY FUNCTION ROOM WITH PROVISION FOR FURNITURES AND FIXTURES	REQUESTER: DR. LUCIA M. SANTOS, RND DEAN, COLLEGE OF HOME ECONOMICS	RECOMMENDING APPROVAL: ARCH. JOSEPH ANDREW L. SAHALUAP DIRECTOR OF PHYSICAL PLANT AND ENGINEERING SERVICES	RECOMMENDING APPROVAL: DR. JOSELUJO D. MADRICAL VICE PRESIDENT FOR ADMIN AND FINANCE	APPROVED BY: DR. MA. CARLA A. OCHOTORENA VICE PRESIDENT	SHEET CONTENTS: MALE CR PLAN INTERIOR SECTION A, B, C AND D TILE LAYOUT	SHEET NO.: A11 11/36	STARS SCHOOL TO ACHIEVE RISE AND SHINE	WUJI WORLDWIDE UNIVERSITY JOURNAL
PHD: 0010577	PTR: 2099901	TIN: 443-013-820	LOCATION: NOROLIT L. BALWAGAN ZAMBOANGA CITY	PHD: 0010577	PTR: 2099901	TIN: 443-013-820			

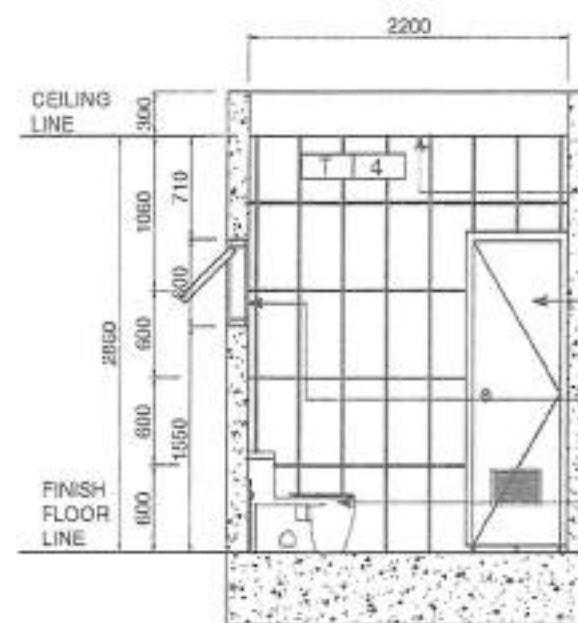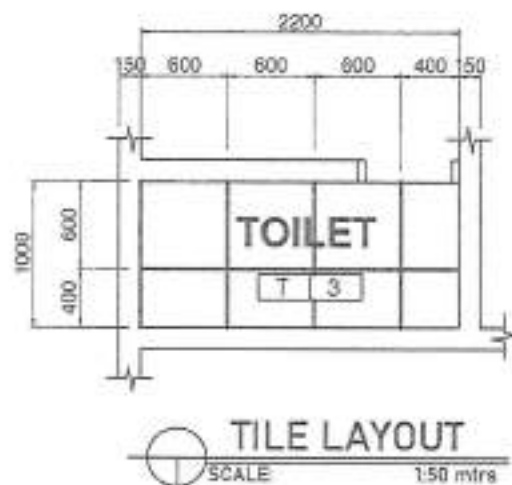

FOR DROP CEILING, USE
3.5mm THK X 1" X 2"
METAL FURRING FOR
THE FRAME AND FIBER
CEMENT BOARD FOR
THE COVERING
6mm X 300mm X 600 mm
WALL TILES, VERTICAL
LAYOUT,
DESIGN & COLOR - FOR
ARCHITECT'S APPROVAL
REFER TO SCHEDULE OF
DOORS & WINDOWS
WATERCLOSET AND
OTHER FIXTURES ARE
SUBJECT FOR APPROVAL
OF THE ARCHITECT

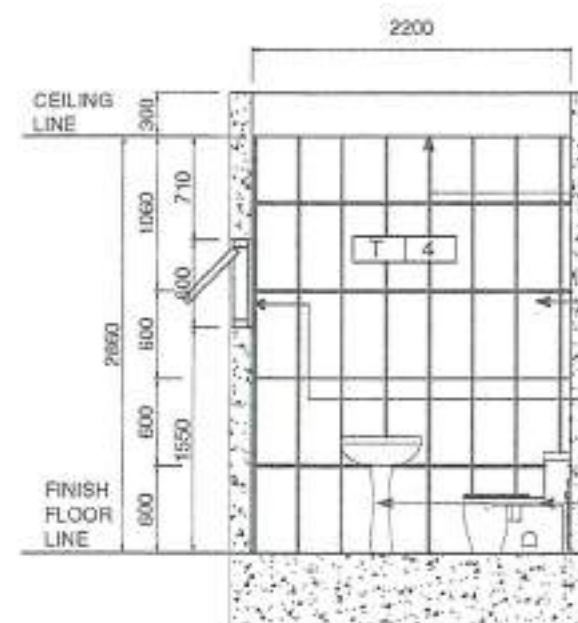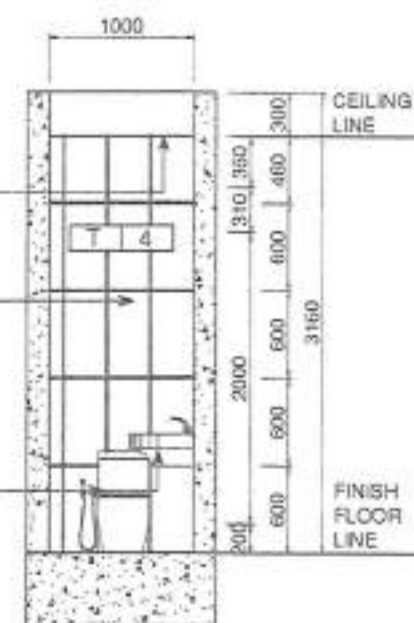

FOR DROP CEILING, USE
3.5mm THK X 1" X 2"
METAL FURRING FOR
THE FRAME AND FIBER
CEMENT BOARD FOR
THE COVERING
6mm X 300mm X 600 mm
WALL TILES, VERTICAL
LAYOUT,
DESIGN & COLOR - FOR
ARCHITECT'S APPROVAL
REFER TO SCHEDULE OF
DOORS & WINDOWS
PEDESTAL LAVATORY AND
OTHER FIXTURES ARE
SUBJECT FOR APPROVAL
OF THE ARCHITECT



	DESIGNED BY: ARCH. JOSEPH ANDREW L. SAHIALUAP UNIVERSITY ARCHITECT	PROJECT TITLE: RENOVATION OF COLLEGE OF HOME ECONOMICS LABORATORY, FUNCTION ROOM WITH PROVISION FOR FURNITURES AND FIXTURES	REQUESTER: DR. LUCIA M. SANTOS, RND DEAN, COLLEGE OF HOME ECONOMICS	RECOMMENDING APPROVAL: ARCH. JOSEPH ANDREW L. SAHIALUAP DIRECTOR OF PHYSICAL PLANT AND ENGINEERING SERVICES	RECOMMENDING APPROVAL: DR. JOSE LUIS D. MADROAL VICE PRESIDENT FOR ADMIN AND FINANCE	APPROVED BY: DR. MA. CARLITA A. OCHOTORENA VICE PRESIDENT	SHEET CONTENTS: TOILET PLAN, INTERIOR SECTION A, B, C, AND D, TILE LAYOUT DRAWN BY: AN. REYES AN. SANCOSON	SHEET NO. A12 12/36	
--	--	--	---	--	---	---	--	--	--